

COLUMN LINE
LETTERS IN ONE DIRECTION,
NUMBERS IN THE OTHER
DIRECTION

DOOR SYMBOL
DOOR NUMBER

WINDOW SYMBOL

EQUIPMENT TAG
TYPE OF EQUIPMENT
EQUIPMENT GROUP

REVISION CLOUD

MATCH LINE
SHADED PORTION IS
THE SIDE CONSIDERED

WORK POINT, CONTROL POINT
OR DATUM POINT

SECTION MARK
INDICATING LOCATION AND
DIRECTION OF SECTION VIEW
AND SHEET PLACEMENT

DETAIL MARK
IDENTIFICATION AND
PLACEMENT ON SHEET

INTERIOR ELEVATION(S)
ELEVATION NUMBER,
IDENTIFICATION AND
SHEET PLACEMENT

ROOM TAG
ROOM NAME
ROOM NUMBER

NEW FINISH GRADE
DRAWN AT 45 DEG.
EXISTING GRADE
LABELED HORIZ.

PROPERTY LINE

NEW OR FINISH
CONTOURS

EXISTING CONTOURS

TOP OF WALL

TOP OF CURB

TOP OF PAVEMENT

ACOUSTIC TILE

BITUMINOUS CONCRETE

BRICK

CERAMIC TILE

CONCRETE

EARTH

GLASS

GYPSUM BOARD

INSULATION BATTS

INSULATION RIGID

METAL

METAL LATH

MORTAR

PLASTER

PLYWOOD

ROCK

SAND

STONE

WOOD, FINISH

WOOD, FRAMING


WOOD, INTERRUPTED

REMOVE OR DEMOLISH

TYPICAL SYMBOLS


TnT GROWN, LLC. SITE ELECTRICAL

1041 SPROWEL CREEK RD.
GARBERVILLE, CA 95542
032-171-027

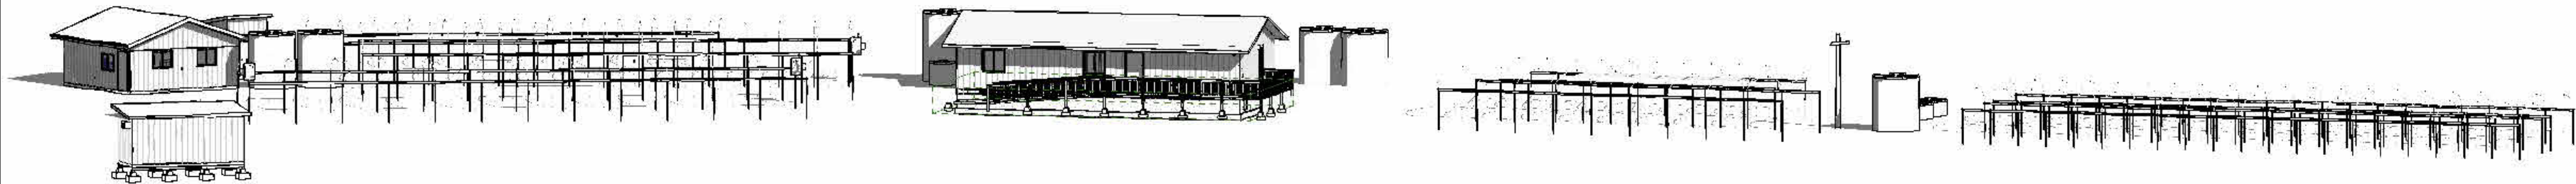

DIRECTIONS TO SITE

FROM BROADWAY ST. (U.S. 101) SOUTH EUREKA,
CONTINUE 66 MI & TAKE EXIT 639A TO GARBERVILLE,
AT THE STOP SIGN, TURN LEFT ON TO SPROWEL CREEK RD.
CONTINUE ON SPROWEL CREEK RD. 0.3 MI,
THE DESTINATION IS ON YOUR LEFT.

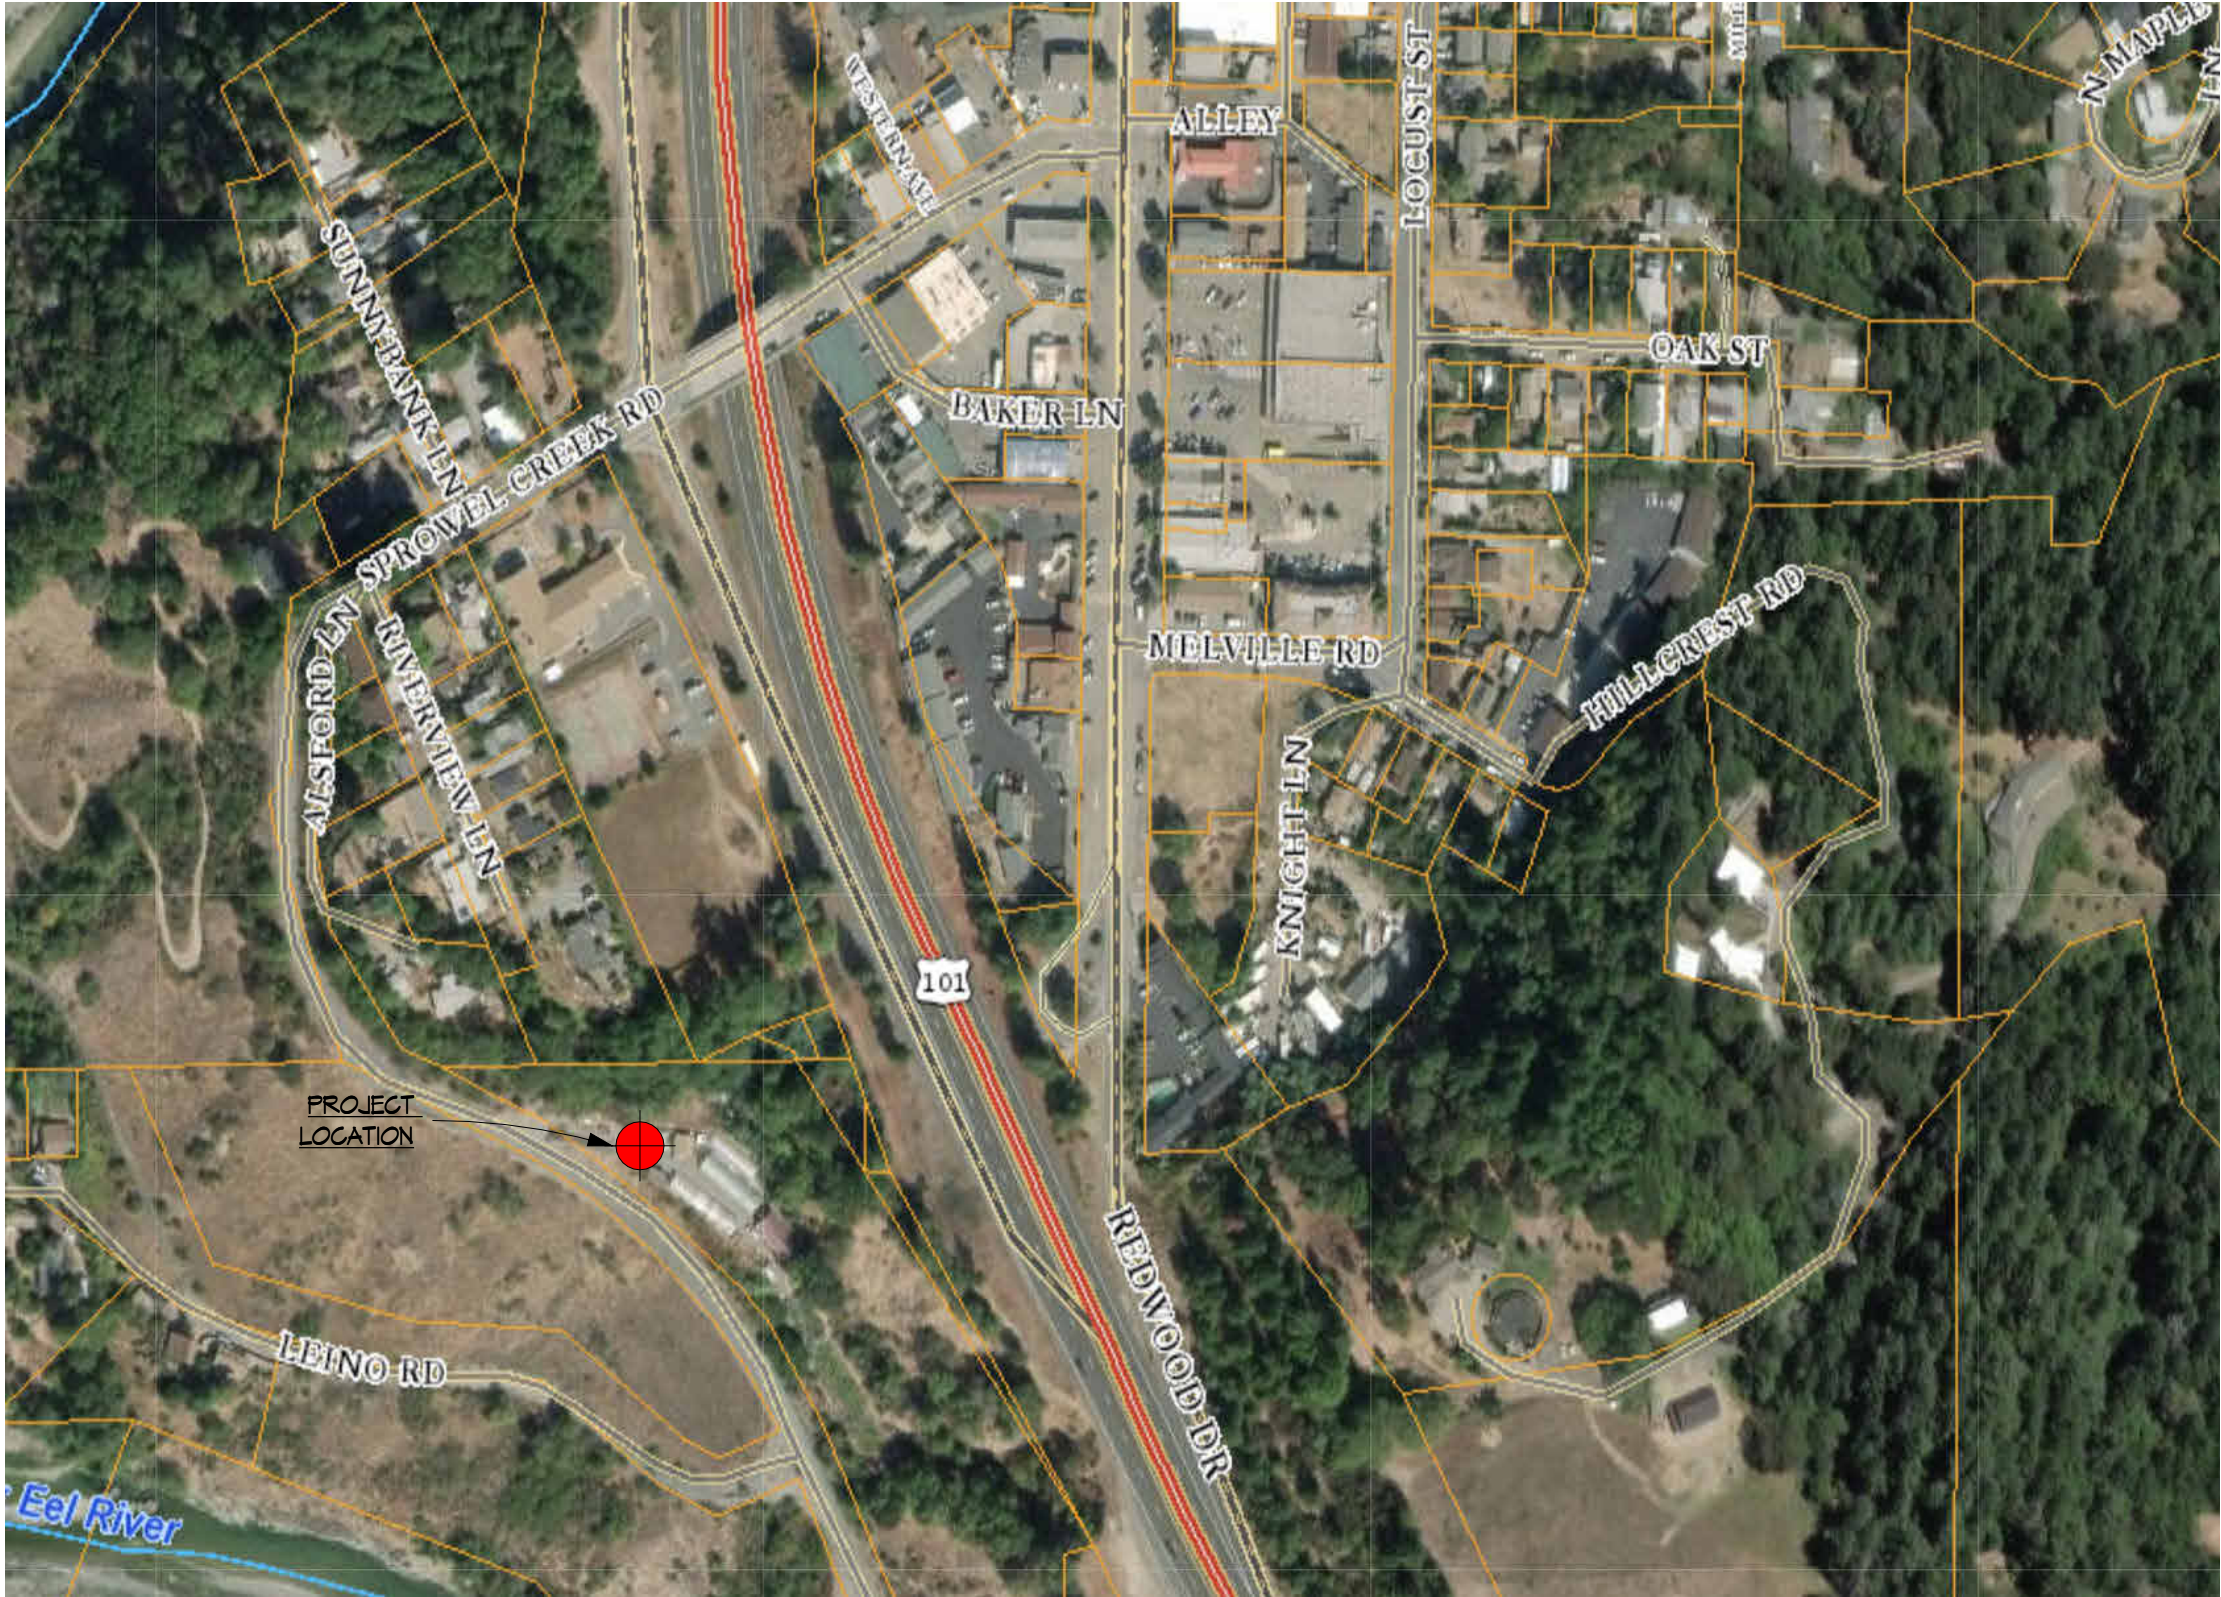

VICINITY MAP

SHEET LIST

SHEET NAME	SHEET NUMBER
TITLE SHEET	G1
PLOT PLAN	1
ELECTRICAL SITE PLAN	E1.1
ENLARGED PLAN NORTH	E1.2
ENLARGED PLAN SOUTH	E1.3
(F) BUILDING ELECTRICAL PLANS	E2.1

PROJECT SCOPE

THE SCOPE OF THIS PROJECT IS TO DOCUMENT THE ELECTRICAL SYSTEM
THAT POWERS THE FACILITY

PARCEL NO.:	032-171-027-000
ZONING:	AG-5-B-5(5)
SITE AREA:	5.19 AC
CONSTRUCTION TYPE:	VARIES
OCCUPANCY:	N/A
TOTAL OCCUPANT LOAD:	AG RELATED
DESCRIPTION OF USE:	N/A
SPRINKLERS:	N/A
NO. OF STORIES:	1
BLDG. HEIGHT:	VARIES
FLOOR AREA:	VARIES

APPLICABLE CODES: CBC 2022, BASED ON THE IBC 2021
2022 CODES FOR CMC, GPC, GEC, CA


SPECIAL INSPECTIONS: NONE

DEFFERRED SUBMITTALS: NONE


ENGINEER:
DTN ENGINEERING
2731 K ST. UNIT A
EUREKA, CA 95501

CONTACT:
DAVID NICOLETT
(916) 215-7769

OWNER:
TnT GROWN LLC

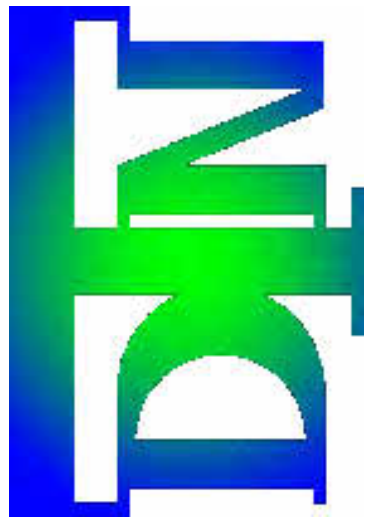

DTN ENGINEERING&CONSULTING
dnicoletti@dtngineering.com

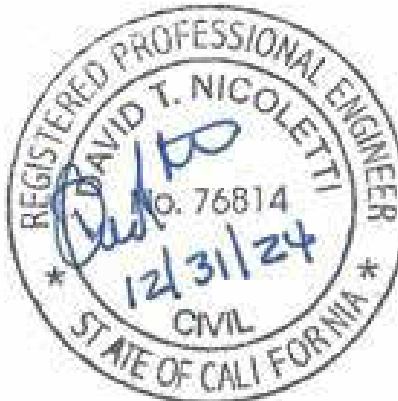[illegible]

TnT GROWN, LLC.
SITE ELECTRICAL
11041 SPROWEL CREEK RD.
GARBERVILLE, CA 95542
APN: 032-171-027

APN:	032-171-027
DRAWN BY:	RKH
DATE:	4/22/2025 12:19:51

TITLE SHEET

SHEET NO

G1
OF 6

RIVERVIEW FARMS TOTAL=4,484~~TNT GROWN TOTAL=5,169~~

ENGINEER

SITE PLAN NOTES

-



VICINITY MAP
N.T.S.

GENERAL NOTES:	
WATER: GARBERVILLE CSD	WASTE WATER: CITY of GARBERVILLE
POWER: PG & E	PHONE:
CREEKS / STREAMS: NONE	TREES TO BE REMOVED: NONE
GRADING: SEE GRADING PLAN	ZONING: AG

CONTRACTOR MUST CONTACT USA DIG AT 800-227-2600 AT LEAST 72 HOURS BEFORE ANY EARTHWORK OR ACTIVITIES THAT MAY IMPACT EXISTING UNDERGROUND UTILITIES.
EXISTING UTILITY ALIGNMENTS BOTH HORIZONTALLY AND VERTICALLY MUST BE VERIFIED BY THE CONTRACTOR PRIOR TO ANY CONSTRUCTION ACTIVITIES.

PROVIDE ADEQUATE WATER STORAGE AND DELIVERY AS OUTLINED BY SRA ORDINANCE AND CALFIRE REQUIREMENTS.

PROVIDE ADEQUATE TURN AROUND AND PULLOUTS AS OUTLINED BY SRA ORDINANCE AND CALFIRE REQUIREMENTS.


THERE ARE NO SCHOOLS, SCHOOL BUS STOPS, PLACES OF WORSHIP, PUBLIC PARKS, OR TRIBAL CULTURAL RESOURCES WITHIN 600' OF CULTIVATION AREAS

THERE ARE NO OFFSITE RESIDENCES WITHIN 300' OF CULTIVATION AREAS.

SHEET
NO. 1 of 1

	SINGLE POLE SWITCH
	DUPLEX RECEPTACLE
	GROUND FAULT RECEPTACLE
	WEATHERPROOF GROUND FAULT RECEPTACLE
	EXHAUST FAN
	WEATHERPROOF JUNCTION BOX
	UNDERGROUND WIRING RUN
	ABOVE GROUND WIRING RUN
	OSCILLATING FAN
	3 TIER GLOVE RACK
	DEHUMIDIFIER
	MINI SPLIT EVAPORATOR
	GAVITA 1930e
	GAVITA 1700e

Wire Size Schedule			
From Panel	To Panel/Circuit	Current	Wire Size
Main Panel	Panel 1	49.12 A	2-#4, 1-#4, 1-#4
Main Panel	Panel 2	54.64 A	2-#3, 1-#3, 1-#3
Main Panel	Panel 3	22.57 A	2-#4, 1-#4, 1-#4
Main Panel	GH 13 N LIGHTS	7.81 A	2-#12, 1-#12, 1-#12
Main Panel	GH 13 S LIGHTS	7.80 A	2-#12, 1-#12, 1-#12
Main Panel	GH 14 LIGHTS	7.80 A	2-#12, 1-#12, 1-#12
Main Panel	GH 15 N LIGHTS	10.40 A	2-#12, 1-#12, 1-#12
Main Panel	GH 15 S LIGHTS	10.40 A	2-#10, 1-#10, 1-#10
Main Panel	GH 16 N LIGHTS	10.40 A	2-#12, 1-#12, 1-#12
Main Panel	GH 16 S LIGHTS	10.40 A	2-#10, 1-#10, 1-#10
Panel 2	GH 10 R LIGHTS	10.41 A	2-#10, 1-#10, 1-#10
Panel 2	GH 10 L LIGHTS	10.41 A	2-#10, 1-#10, 1-#10
Panel 2	GH 11 R LIGHTS	7.81 A	2-#12, 1-#12, 1-#12
Panel 2	GH 11 L LIGHTS	10.41 A	2-#10, 1-#10, 1-#10
Panel 2	GH 12 N LIGHTS	7.81 A	2-#10, 1-#10, 1-#10
Panel 2	GH 12 S LIGHTS	7.81 A	2-#12, 1-#12, 1-#12

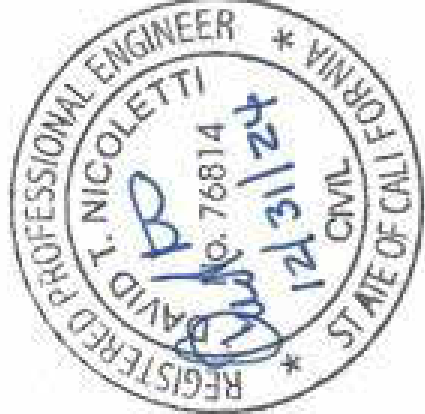[illegible]

SITE ELECTRICAL
1041 SPROWEL CREEK RD.
GARBERVILLE, CA 95542
APN: 032-171-027




APN:	032-171-027
DRAWN BY:	RKH
DATE:	4/22/2025 12:19:56 PM

ELECTRICAL SITE PLAN

SHEET NO

E1.1
OF 6

\$	SINGLE POLE SWITCH
	DUPLEX RECEPTACLE
GFCI	GROUND FAULT RECEPTACLE
GFCI WP	WEATHERPROOF GROUND FAULT RECEPTACLE
	EXHAUST FAN
JB	WEATHERPROOF JUNCTION BOX
---	UNDERGROUND WIRING RUN
—	ABOVE GROUND WIRING RUN
	OSCILLATING FAN
	3 TIER CLONE RACK
	DEHUMIDIFIER
	MINI SPLIT EVAPORATOR
	GAVITA 1930e
	GAVITA 1700e

 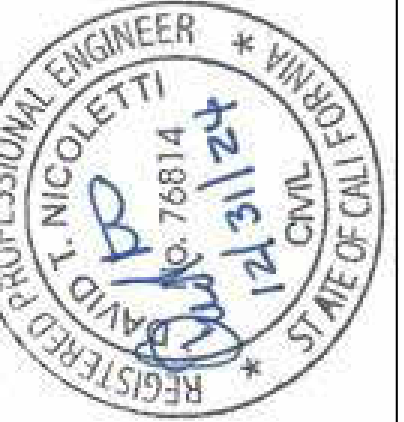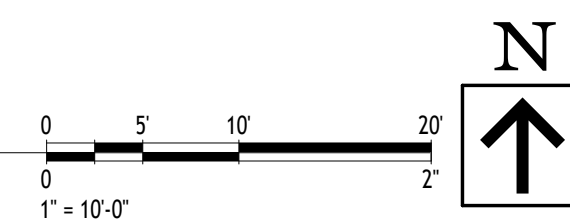[illegible]

SITE ELECTRICAL
1041 SPROWEL CREEK RD.
GARBERVILLE, CA 95542
APN: 032-171-027

PN:	032-171-027
DRAWN BY:	RKH
DATE:	4/22/2025 12:20:01 PM

ENLARGED PLAN NORTH


EET NO.
E1.2
OF 6

W:\Project\032-171-027 TnT Grown\Model\TnT Site Electrical.rvt

ELECTRICAL SYMBOLS	
	SINGLE POLE SWITCH
	DUPLEX RECEPTACLE
	GROUND FAULT RECEPTACLE
	WEATHERPROOF GROUND FAULT RECEPTACLE
	EXHAUST FAN
	WEATHERPROOF JUNCTION BOX
	UNDERGROUND WIRING RUN
	ABOVE GROUND WIRING RUN
	OSCILLATING FAN
	3 TIER GLOVE RACK
	DEHUMIDIFIER
	MINI SPLIT EVAPORATOR
	GAVITA 1930e
	GAVITA 1700e



Enlarged Electrical Plan South
1" = 10'-0"

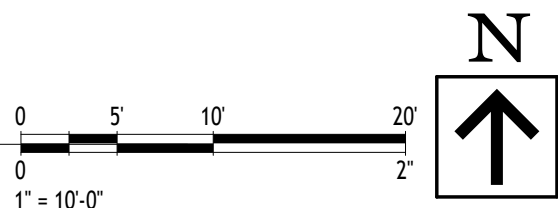


SITE ELECTRICAL
1041 SPROWEL CREEK RD.
GARBERVILLE, CA 95542
APN: 032-171-027


APN: 032-171-027
DRAWN BY: RKH
DATE: 4/22/2025 12:20:05 PM

ENLARGED PLAN SOUTH

SHEET NO.
E1.3
OF 6

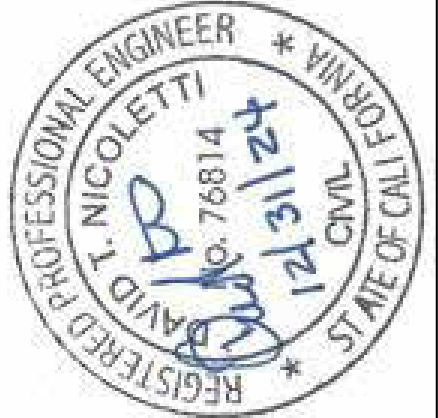


NO.	HISTORY / REVISION	BY	CHKD	DATE

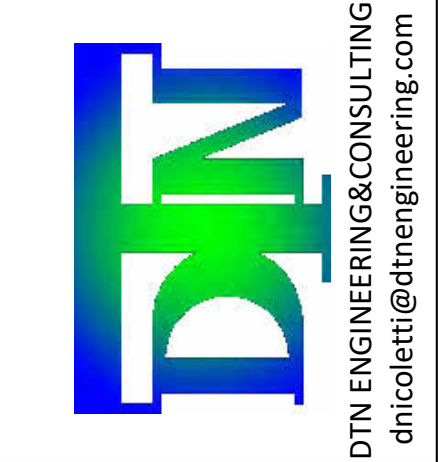

1. EMERGENCY EXIT LIGHTING SHALL BE ILLUMINATED AT ALL TIMES AND TO A DURATION OF NOT LESS THAN 90 MINUTES IN THE EVENT OF A POWER LOSS, AND THAT MEANS OF EGRESS SHALL BE ILLUMINATED AT ALL TIMES SPACE IN OCCUPED. (CEC 100B, 101B).
2. ALL OUTLETS IN WET LOCATIONS TO BE GFCI CEC210.8 (B).
3. ALL ELECTRICAL WIRING AND EQUIPMENT SUBJECT TO PHYSICAL DAMAGE SHALL BE PROTECTED. CEC541.5 (E)
4. ALL ELECTRICAL EQUIPMENT, CONDUIT, FITTINGS ETC. TO BE SECURELY FASTENED AND SUPPORTED BY AN APPROVED MEANS IN ACCORDANCE WITH 2019 CEC
5. PROVIDE WORKING CLEARANCES AROUND ELECTRICAL EQUIPMENT AND 36" MIN. DEPTH. CEC 110.26, 230.70 (A)(1), 230.91, 240.24
6. SERVICE EQUIPMENT IS IDENTIFIED AS SUITABLE FOR USE AS SERVICE EQUIPMENT. CEC 230.66
7. ALL EXTERIOR ELECTRICAL PANEL BOARDS & JUNCTION BOXES TO BE WEATHERPROOF AND LISTED FOR DAMP/WET LOCATIONS. CEC 408.51, 312.2 (A)
8. UNOBSTRUCTED FORWARD REACH AND UNOBSTRUCTED SIDE REACH FOR ELECTRICAL RECEPTACLE OUTLETS 48" MAXIMUM TO TOP OF BOX AND 15" MINIMUM TO BOTTOM OF BOX ABOVE FINISH FLOOR. CEC11B-308.12, 11B-308.2, 11B-308.3

	SINGLE POLE SWITCH
	DUPLEX RECEPTACLE
	GFCI
	WEATHERPROOF GROUND FAULT RECEPTACLE
	EXHAUST FAN
	WEATHERPROOF JUNCTION BOX
	UNDERGROUND WIRING RUN
	ABOVE GROUND WIRING RUN
	OSCILLATING FAN
	3 TIER CLONE RACK
	DEHUMIDIFIER
	MINI SPLIT EVAPORATOR
	GAVITA 1930e
	GAVITA 1700e

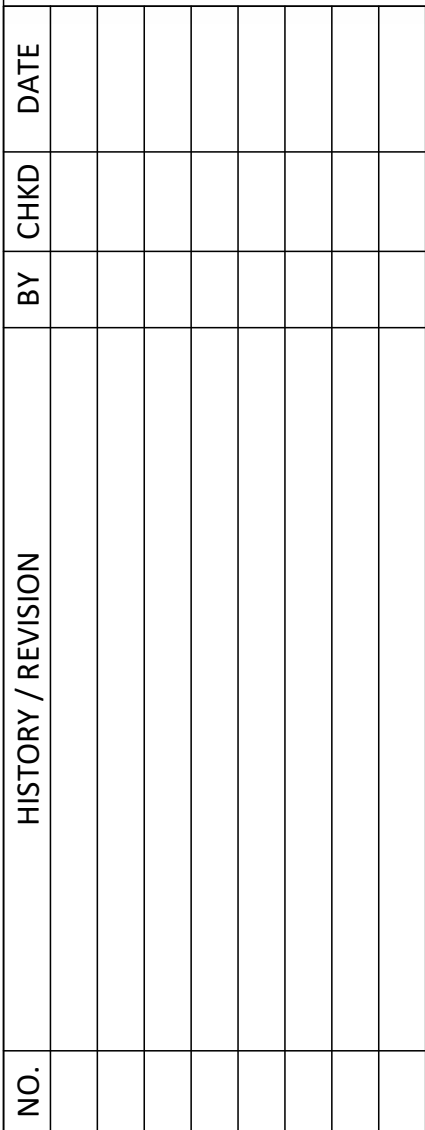

APN:	032-171-027
DRAWN BY:	RKH
DATE:	4/22/2025 12:20:08 PM

(P) BUILDING ELECTRICAL
PLANS

SHEET NO.

E2.1
OF 6